



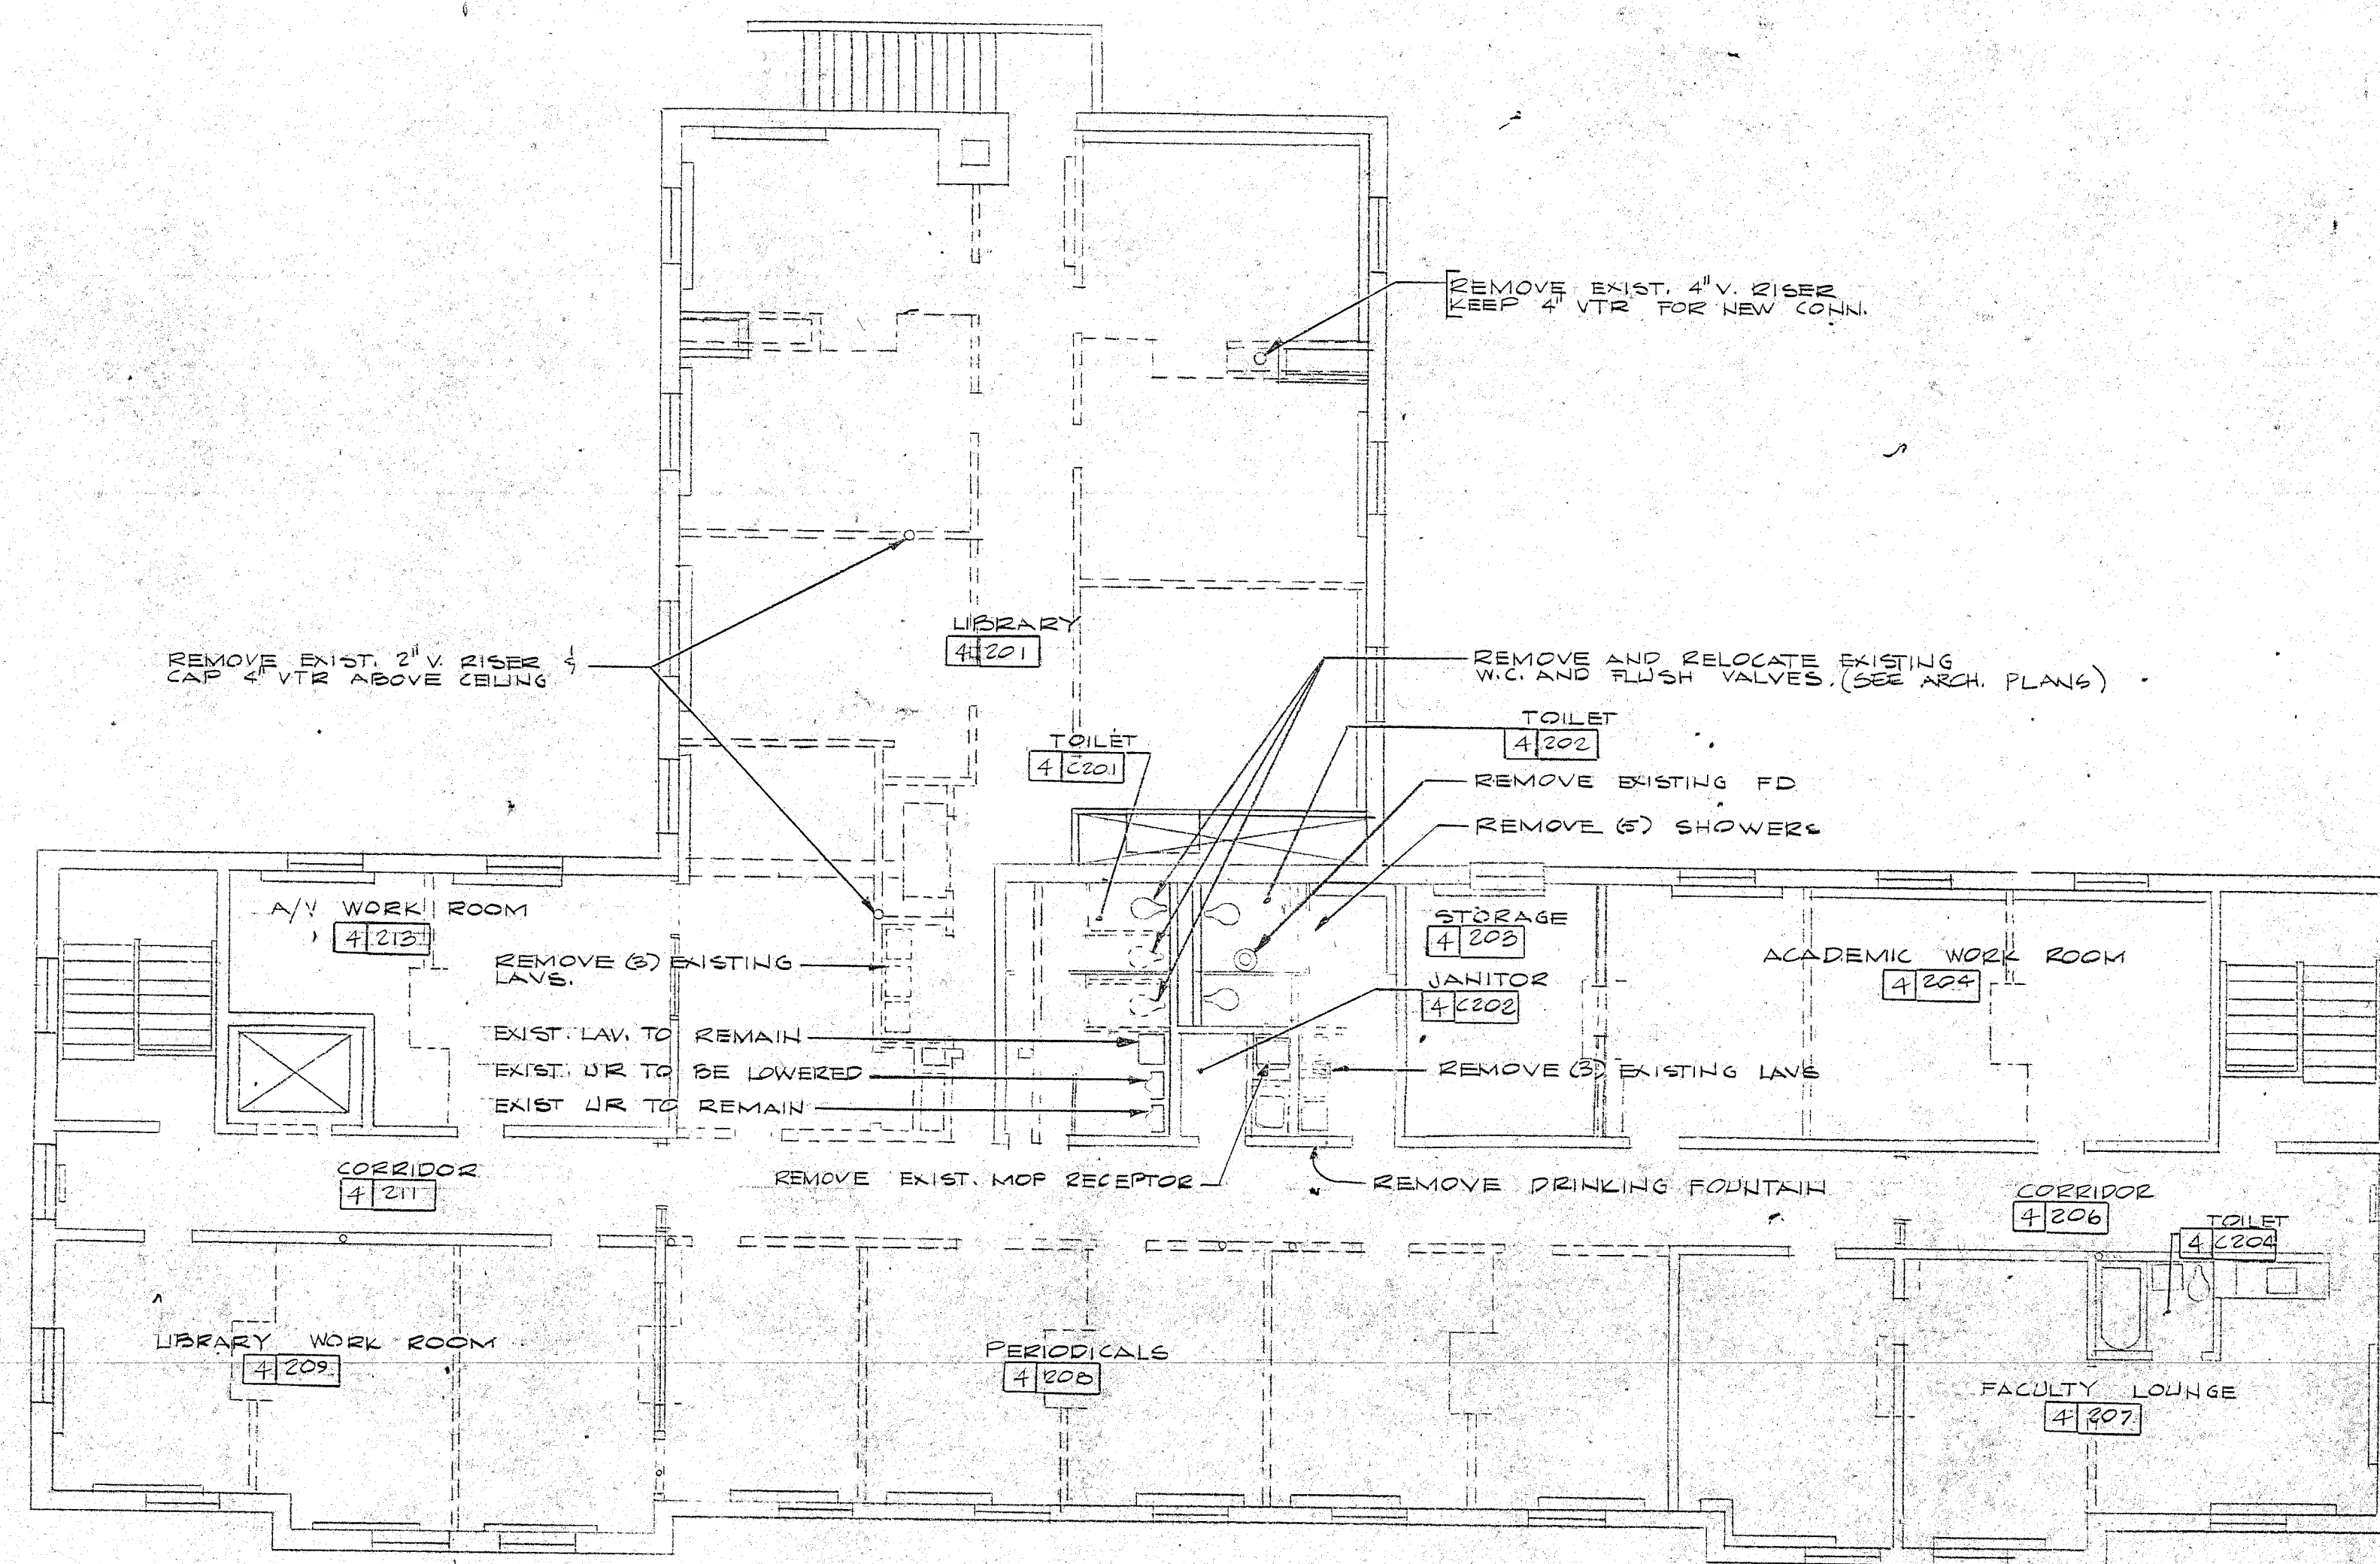

RENOVATION WORK
SECOND FLOOR PLAN


SCALE: 1/8" = 1'-0"

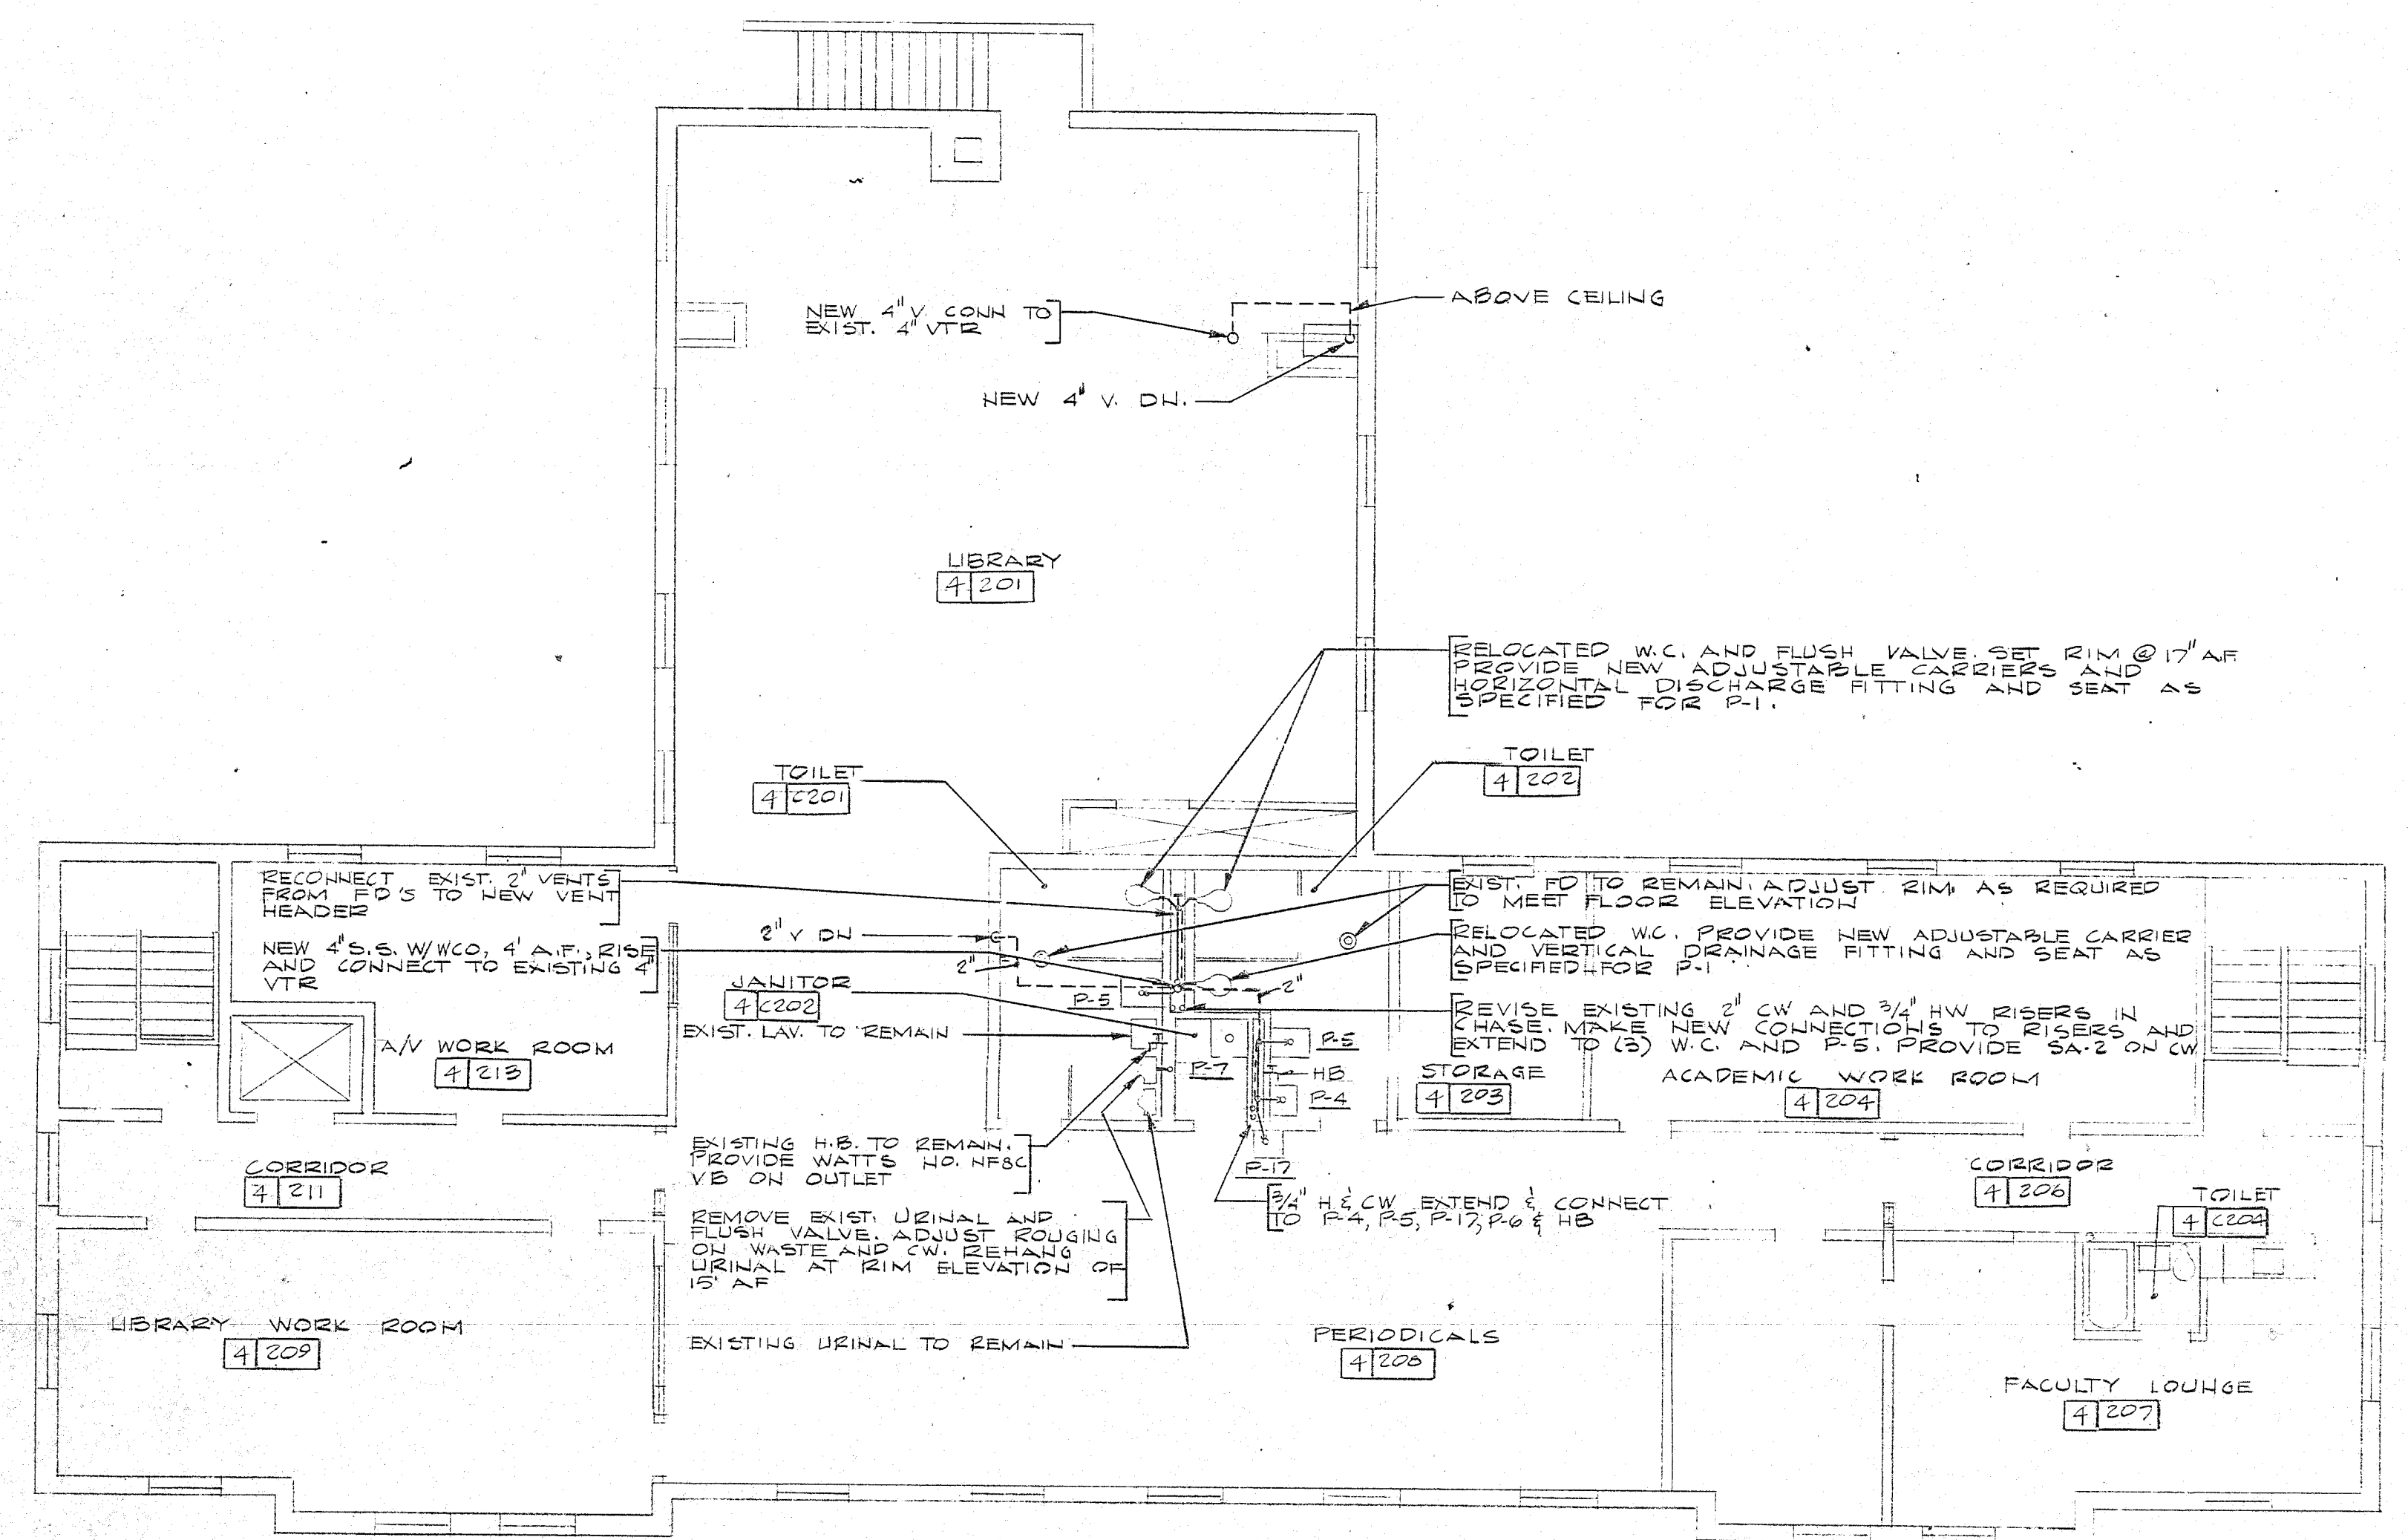

NEW WORK
SECOND FLOOR PLAN


SCALE: 1/8" = 1'-0"

NOTE:
RECONNECT EXISTING ROOF DRAIN
WHEN MOVED FOR REROOFING.
SEE DETAIL ON P-1

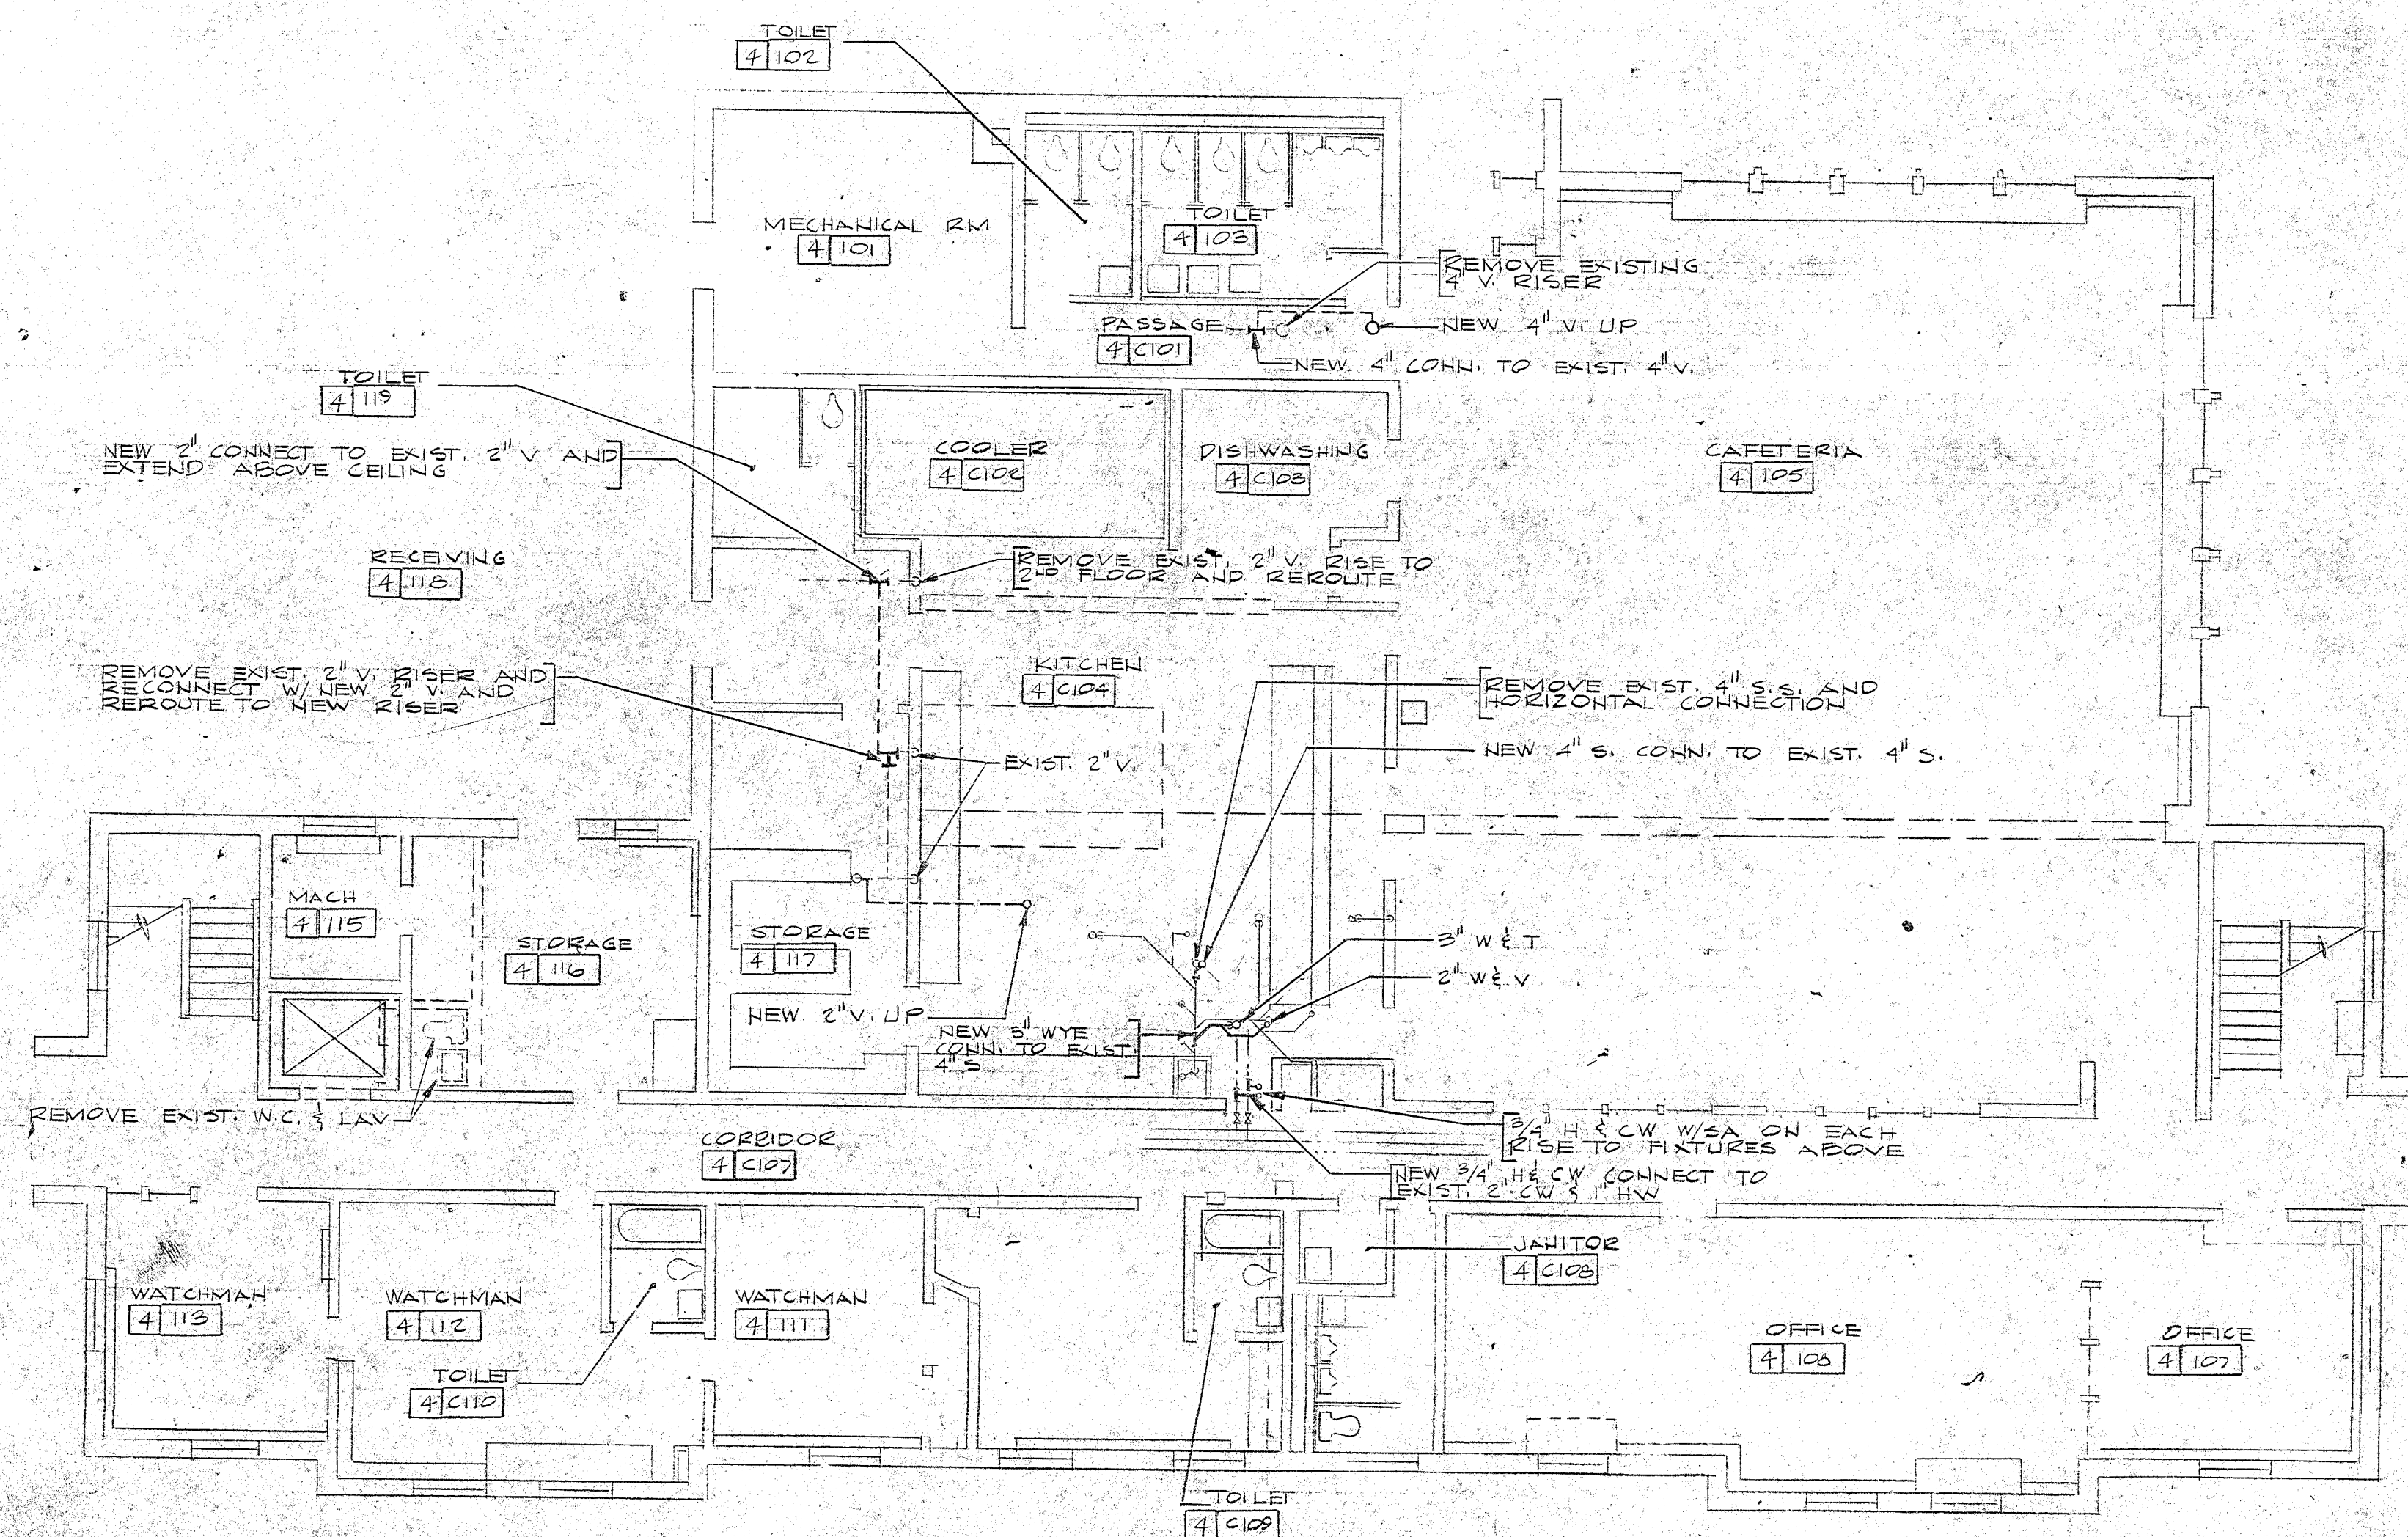


FIRST FLOOR PLAN

SCALE: 1/8" = 1'-0"

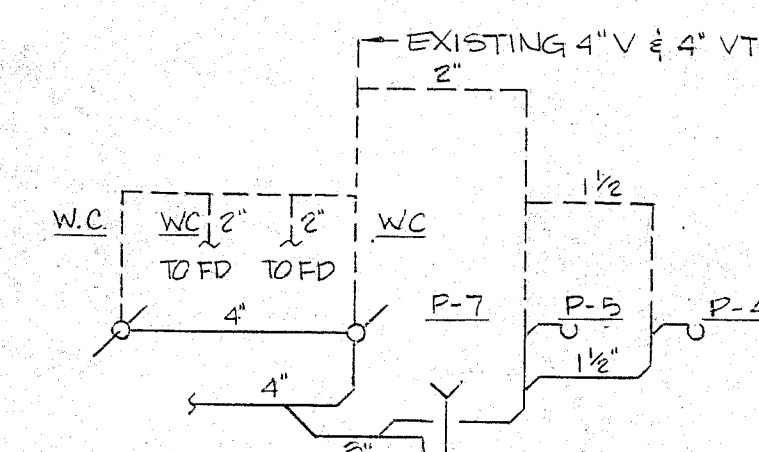

SANITARY RISER "A"
NO SCALE

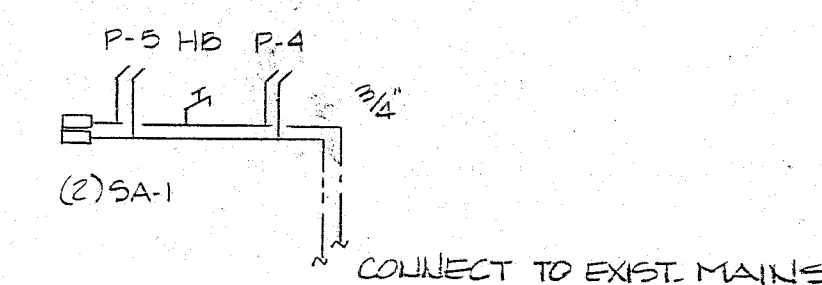

SUPPLY RISER "A"
NO SCALE

- NOTES:
1. ALL FIXTURES AND WALLS IN LIGHTER DASHED LINES ARE TO BE REMOVED. SEE ARCH. DRAWINGS ALSO.
 2. SEE PLANS A-11 & S-BUS FOR ALT. NO. 1.

REVISIONS			Project Additions & Alterations to the Norfolk County Agricultural High School	
NO.	DESCRIPTION	DATE	THE COMMONWEALTH OF MASSACHUSETTS BUREAU OF BUILDING CONSTRUCTION NORFOLK COUNTY COMMISSION	
			BUILDING 4-CAFETERIA BUILDING FLOOR PLANS	
			DRUMMEY ROSANE ANDERSON ARCHITECTS ENGINEERS GREENLEAF ENGINEERS	
			SCALE 1/8" = 1'-0"	
			DATE NOV 14, 1960	